


# STATISTICS

Description	Symbol	Avg	Max	Min	Max/Min	Avg/Min
Workplane	+	53.2 fc	59.3 fc	36.9 fc	1.6:1	1.4:1

# LUMINAIRE SCHEDULE

Symbol	Label	Qty	Catalog Number	Description	Lamp	File	Lumens	LLF	Watts
□	LM-1	40	2RT5 28T5	VOLUMETRIC RECESSED LIGHTING FIXTURE.	TWO 28-WATT T-5 LINEAR FLUORESCENT, RATED 2730 LUMENS EACH AT 25C AMBIENT.	lit13260.IES	2730	0.81	60

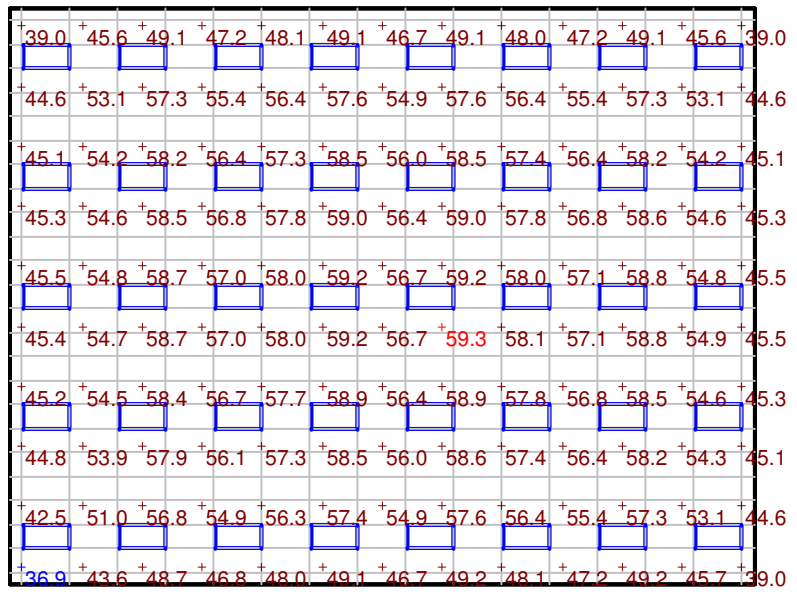

## Plan View

Scale 1" = 16'



Designer

Date  
Feb 8 2007

Scale

Drawing No.